

GENERAL NOTES :-


THIS DRAWING HAS BEEN PRODUCED WITH A PLOT SCALE ACCURACY OF 1:50

BUILDING SURVEY KEY :-


- ⊖ - room height
- ⊖ - floor boards
- ⊖ - pipe diameter
- ⊖ - alarm box
- ⊖ - arch head height
- ⊖ - back drop
- ⊖ - brick
- ⊖ - concrete
- ⊖ - cable riser
- ⊖ - fuse box
- ⊖ - door height
- ⊖ - depth
- ⊖ - electricity metre
- ⊖ - electricity
- ⊖ - fire place
- ⊖ - floor to head height
- ⊖ - floor level
- ⊖ - gas riser
- ⊖ - gas metre
- ⊖ - gas riser
- ⊖ - hand dryer
- ⊖ - heater
- ⊖ - hot water tank
- ⊖ - inspection cover
- ⊖ - invertebrate cover
- ⊖ - ordnance survey bench mark
- ⊖ - quarry tiles
- ⊖ - radiator
- ⊖ - roof light
- ⊖ - rain water pipe
- ⊖ - soil filled chamber
- ⊖ - floor to sill height
- ⊖ - arch springing point height
- ⊖ - soil springing point height
- ⊖ - soil vent pipe
- ⊖ - suspended ceiling
- ⊖ - soil vent pipe
- ⊖ - heated towel rail
- ⊖ - temporary bench mark
- ⊖ - threshold level
- ⊖ - top of tank
- ⊖ - top of pipe
- ⊖ - top of tank
- ⊖ - underside height
- ⊖ - unable to lift
- ⊖ - vent pipe
- ⊖ - water fountain
- ⊖ - water filled chamber
- ⊖ - waste pipe

SERVICES KEY :-

- ⊖ - 3 Vn
- ⊖ - 1 Vn
- ⊖ - 2 Vn
- ⊖ - 3 Vn
- ⊖ - 4 Vn
- ⊖ - 5 Vn
- ⊖ - 6 Vn
- ⊖ - 7 Vn
- ⊖ - 8 Vn
- ⊖ - 9 Vn
- ⊖ - 10 Vn
- ⊖ - 11 Vn
- ⊖ - 12 Vn
- ⊖ - 13 Vn
- ⊖ - 14 Vn
- ⊖ - 15 Vn
- ⊖ - 16 Vn
- ⊖ - 17 Vn
- ⊖ - 18 Vn
- ⊖ - 19 Vn
- ⊖ - 20 Vn
- ⊖ - 21 Vn
- ⊖ - 22 Vn
- ⊖ - 23 Vn
- ⊖ - 24 Vn
- ⊖ - 25 Vn
- ⊖ - 26 Vn
- ⊖ - 27 Vn
- ⊖ - 28 Vn
- ⊖ - 29 Vn
- ⊖ - 30 Vn
- ⊖ - 31 Vn
- ⊖ - 32 Vn
- ⊖ - 33 Vn
- ⊖ - 34 Vn
- ⊖ - 35 Vn
- ⊖ - 36 Vn
- ⊖ - 37 Vn
- ⊖ - 38 Vn
- ⊖ - 39 Vn
- ⊖ - 40 Vn
- ⊖ - 41 Vn
- ⊖ - 42 Vn
- ⊖ - 43 Vn
- ⊖ - 44 Vn
- ⊖ - 45 Vn
- ⊖ - 46 Vn
- ⊖ - 47 Vn
- ⊖ - 48 Vn
- ⊖ - 49 Vn
- ⊖ - 50 Vn

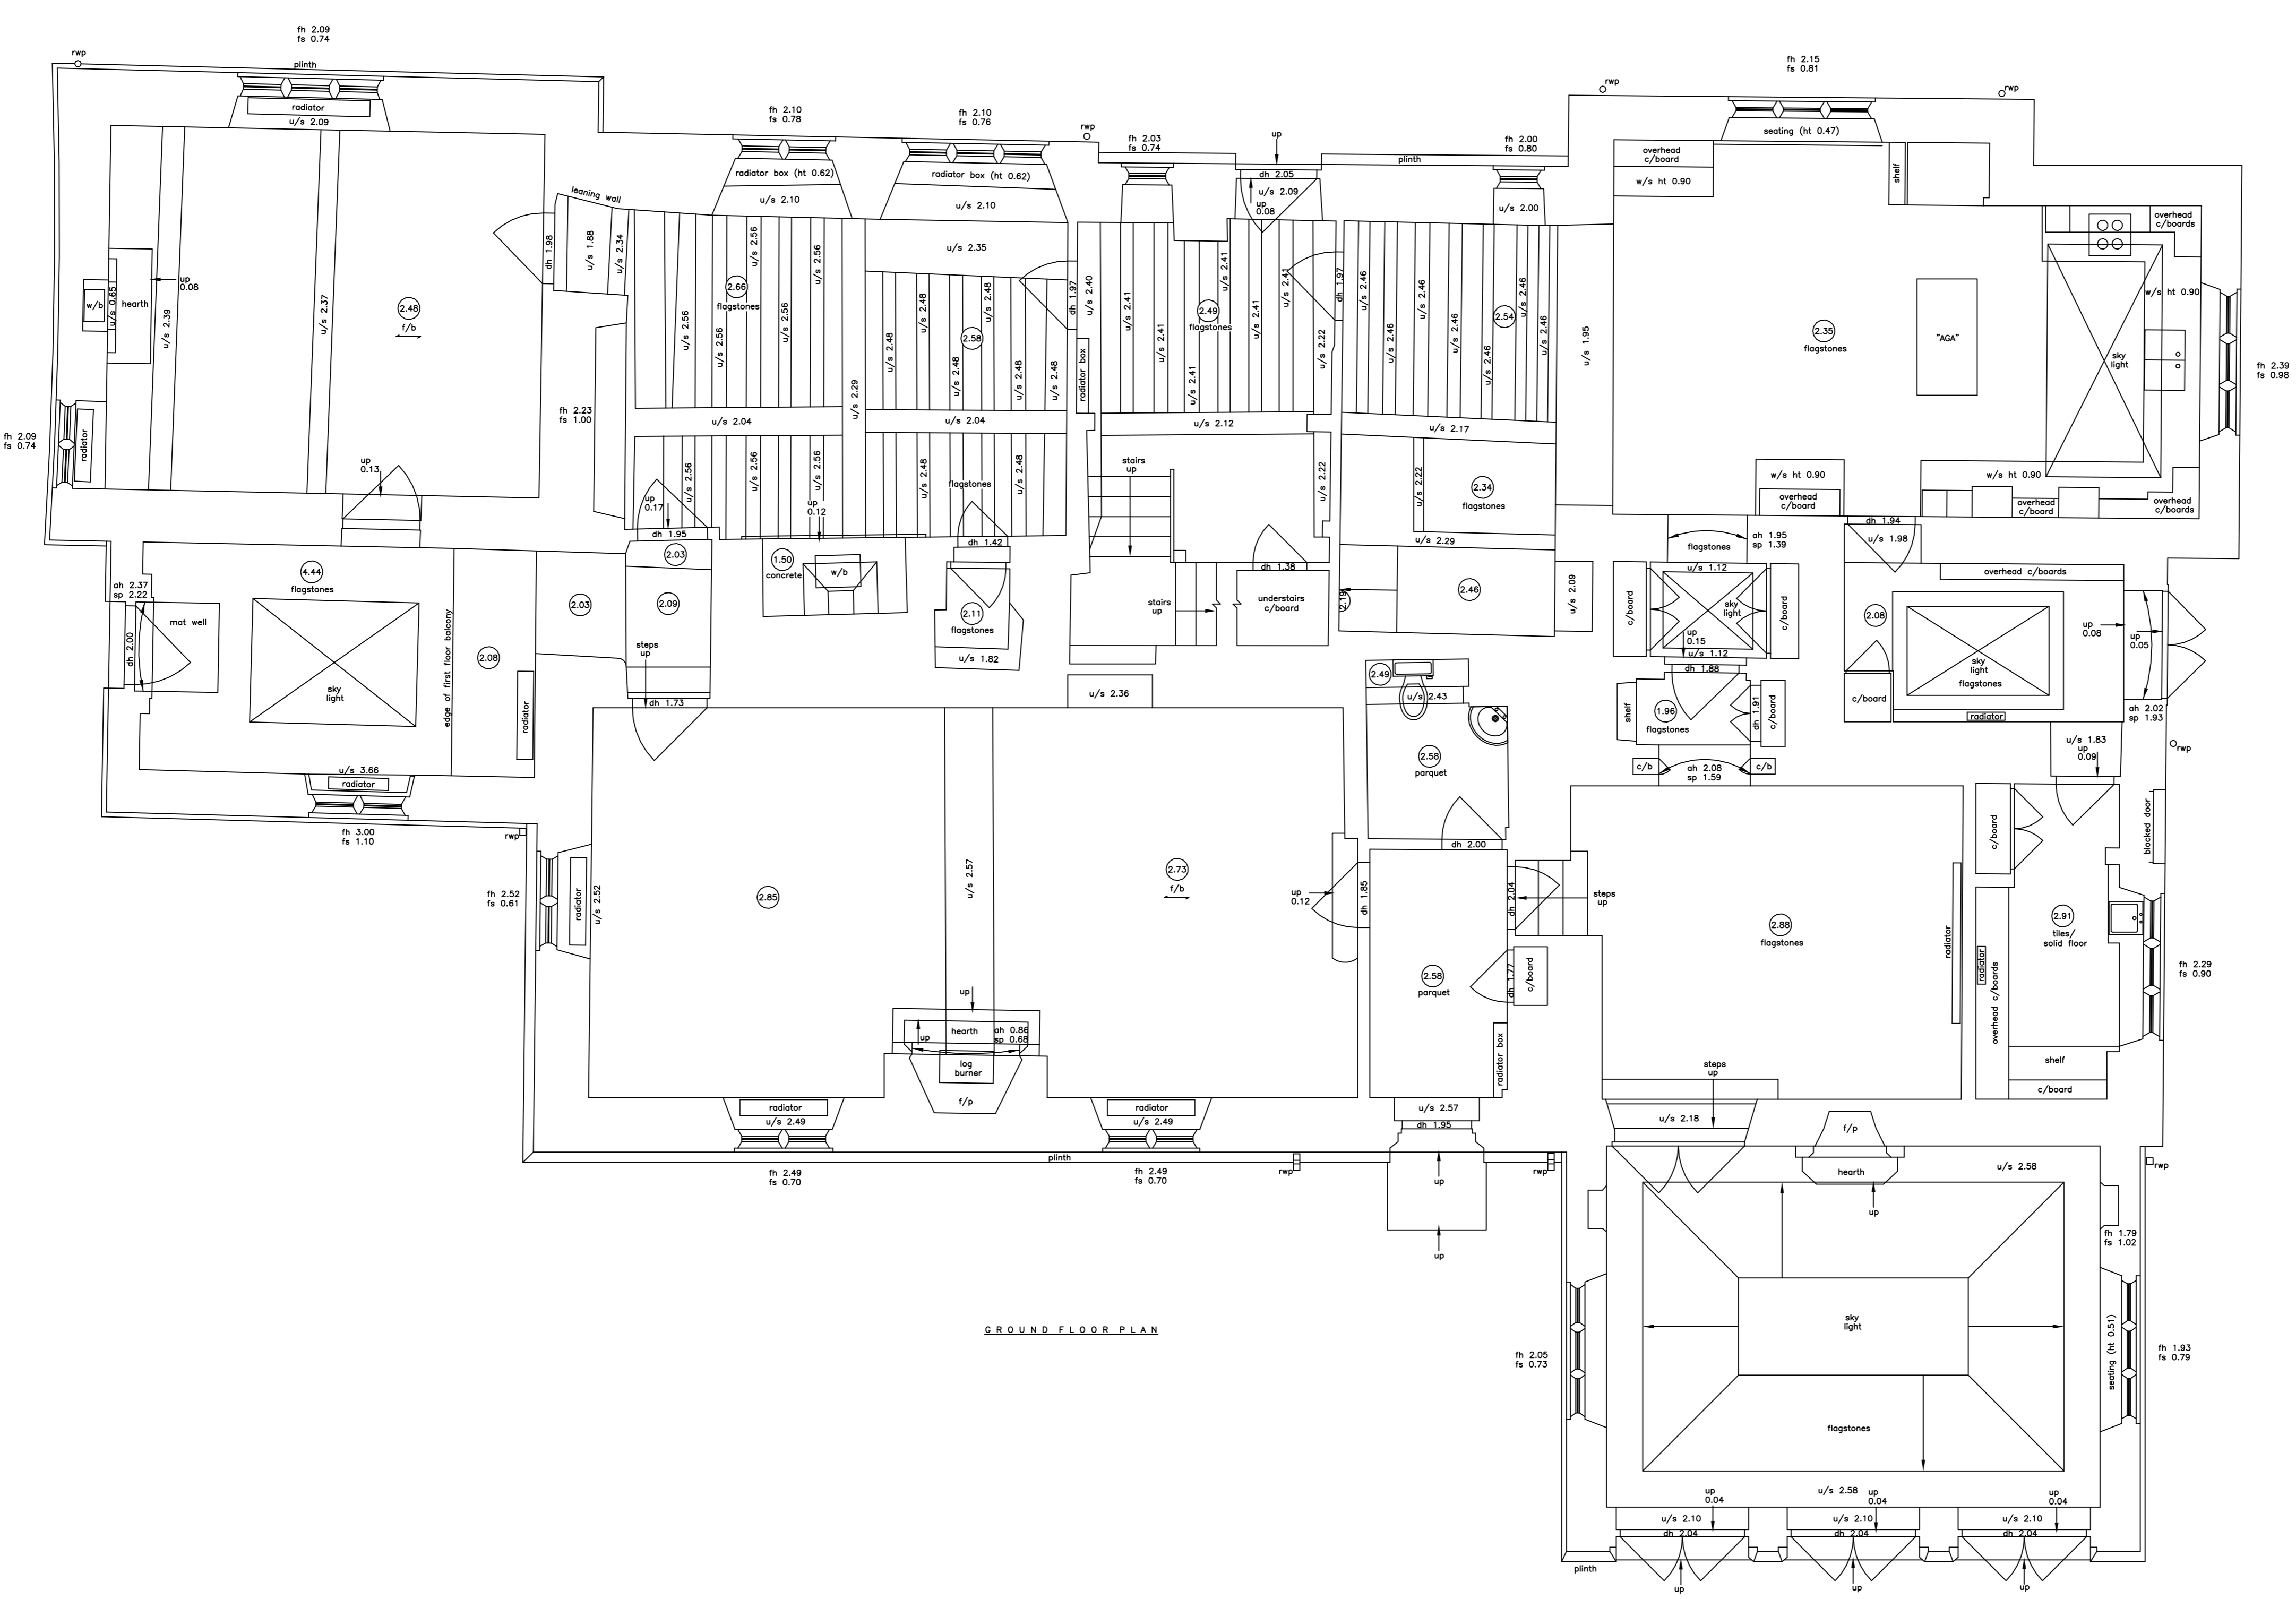

NORTH POINT :-

 

OKFNCPF"UWTXG [ "NVF

HEAD OFFICE  
 Cromwell House, Westfield Road, Southam, Warwickshire, CV47 0JH.  
 Tel: 01926 810811 Fax: 01926 810812  
 E-Mail: mail@midlandsurvey.co.uk  
 www.midlandsurvey.co.uk

Client	
Project	
Title	GROUND FLOOR PLAN
Date	
Scale	1:50BA1
Dwg No	
Surveyor	
Checked	

VQRQ I TCRJECN"NCPE-UWTXG [ QTU"WWNV [ UWTXG [ QTU  
 DWKNFP I"OGCUWTGOGPV"UWTXG [ QTU"SF"NCUGTUECPPI

